



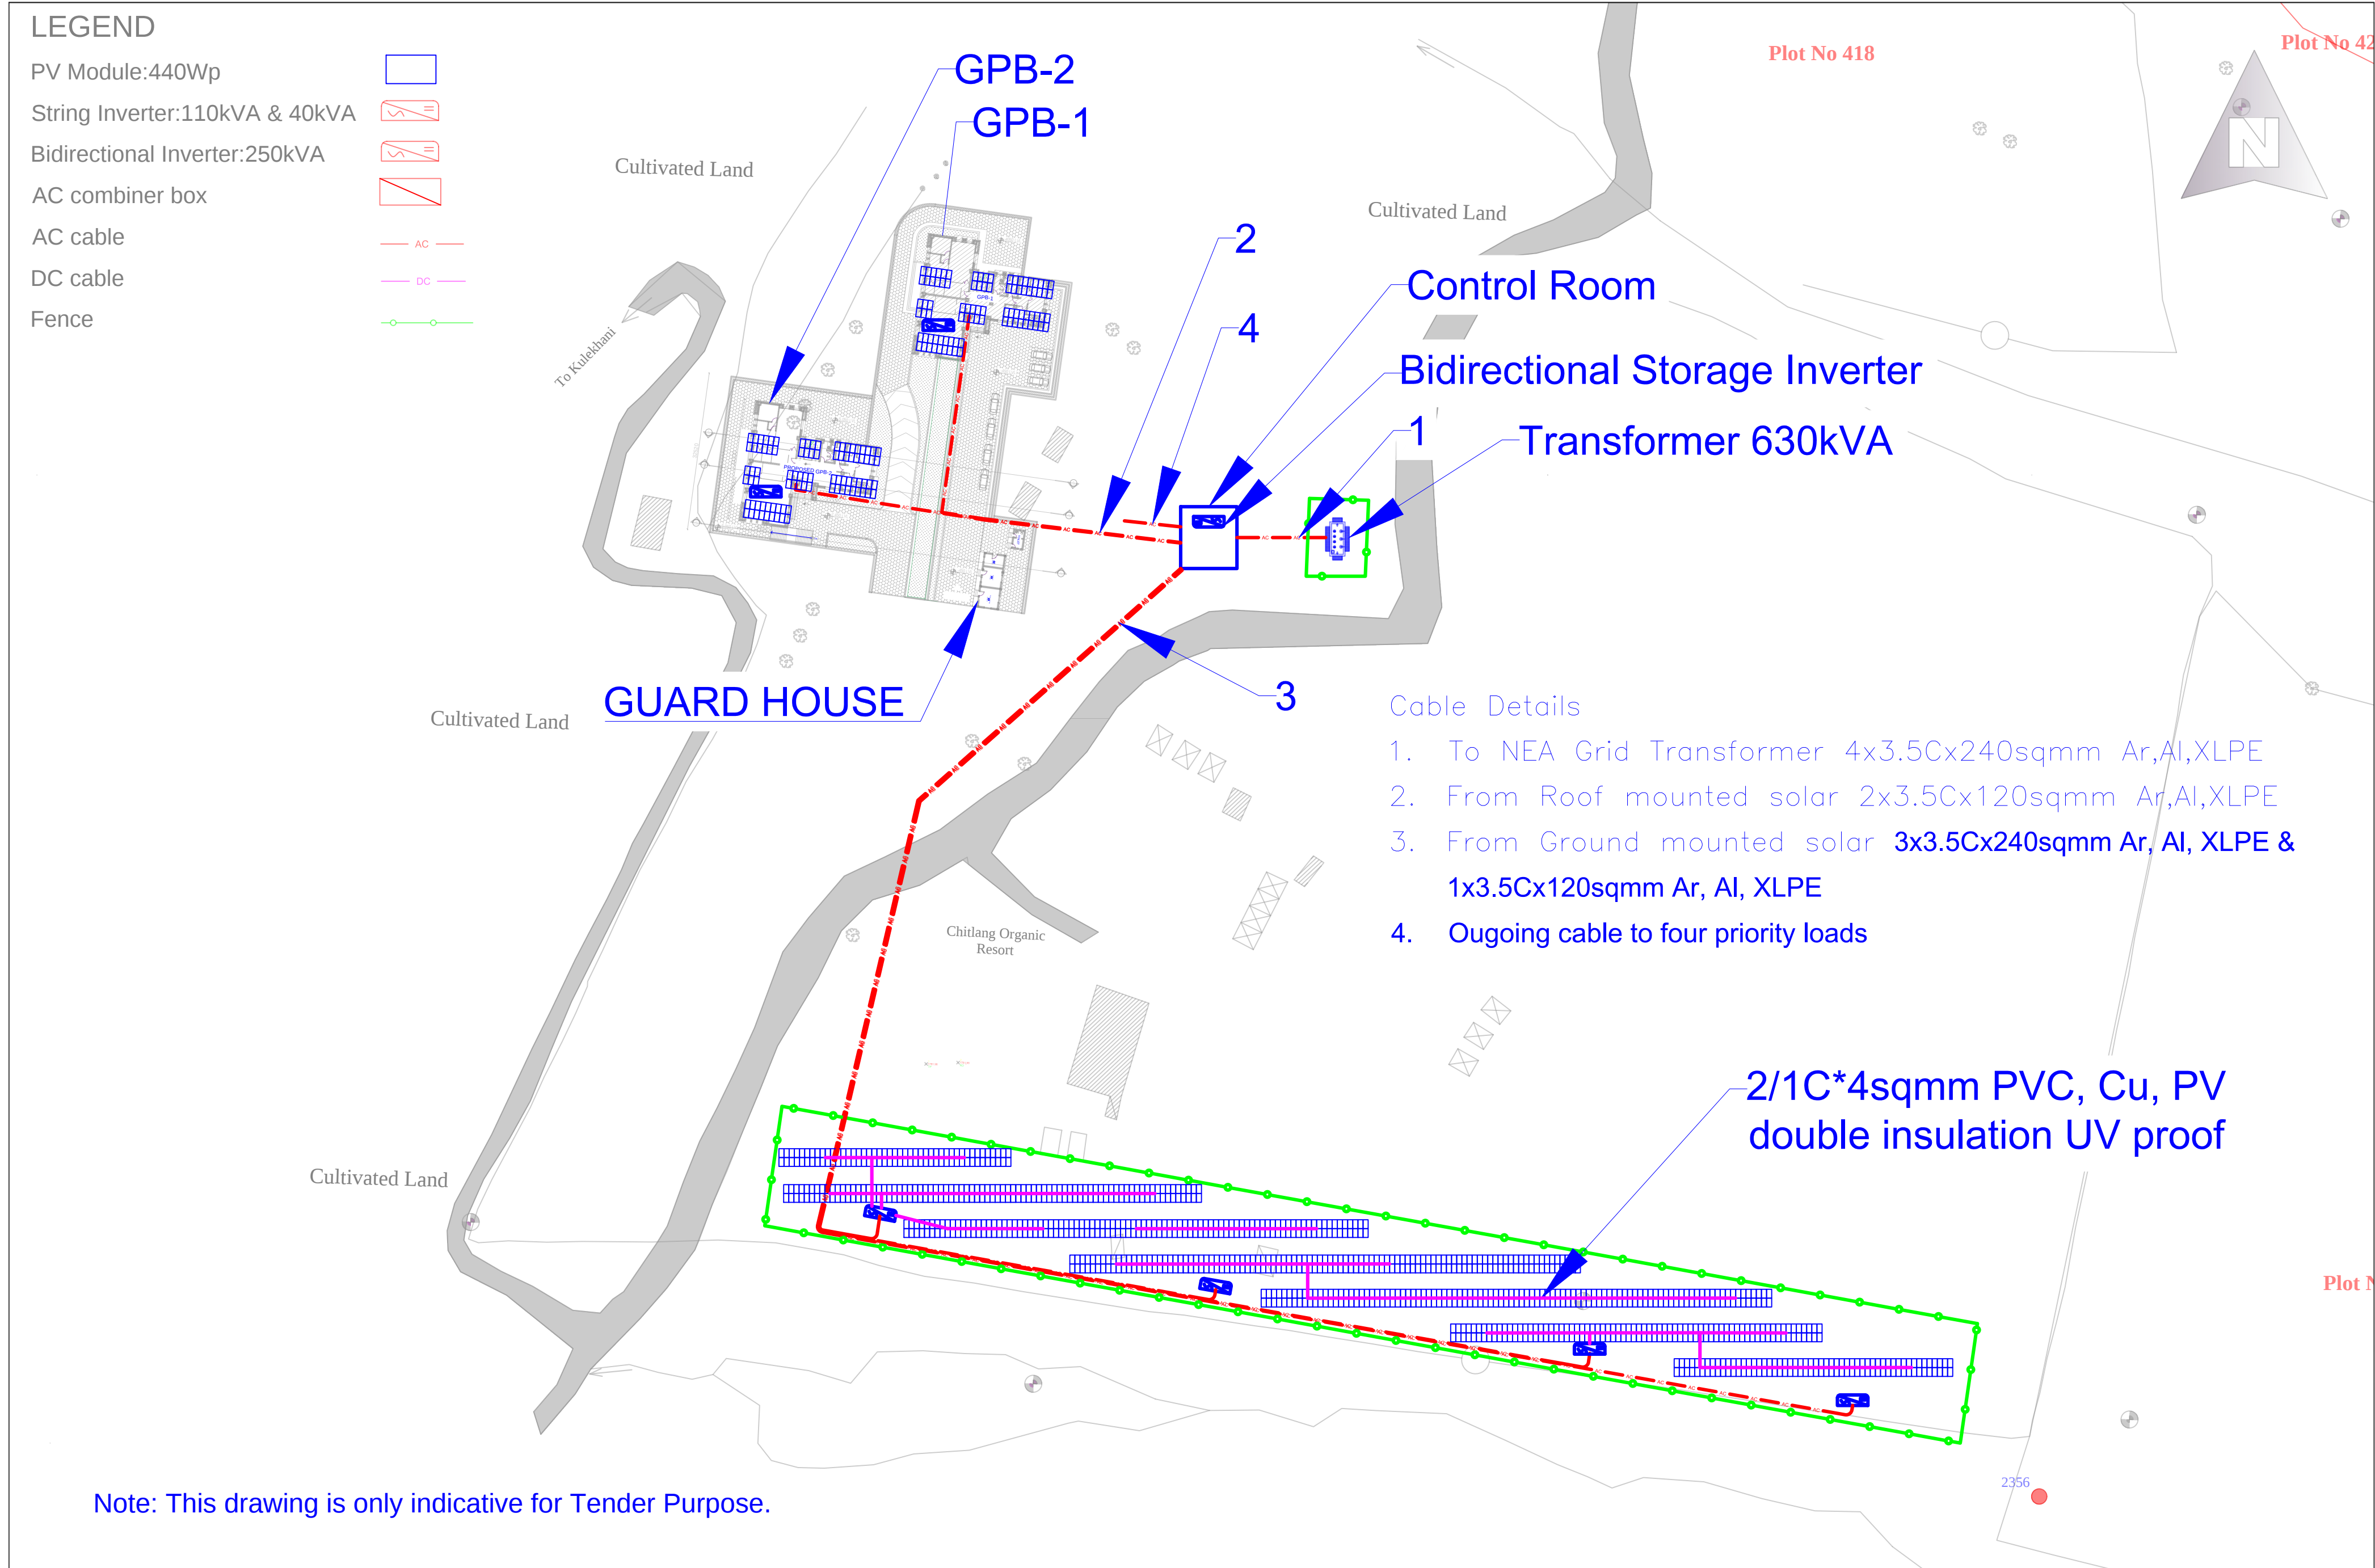




Madan Bhandari University of Science and Technology Chitlang, Makwanpur, Nepal	Project Name: 500kWp MBUST Solar Project Chitlang, Makwanpur, Nepal	Title: PV Layout Plan	DESIGNED BY:	Scale Not in Scale	Note:	Date: August 2021
			CHECKED BY:			
			APPROVED BY:			Drawing No. 1

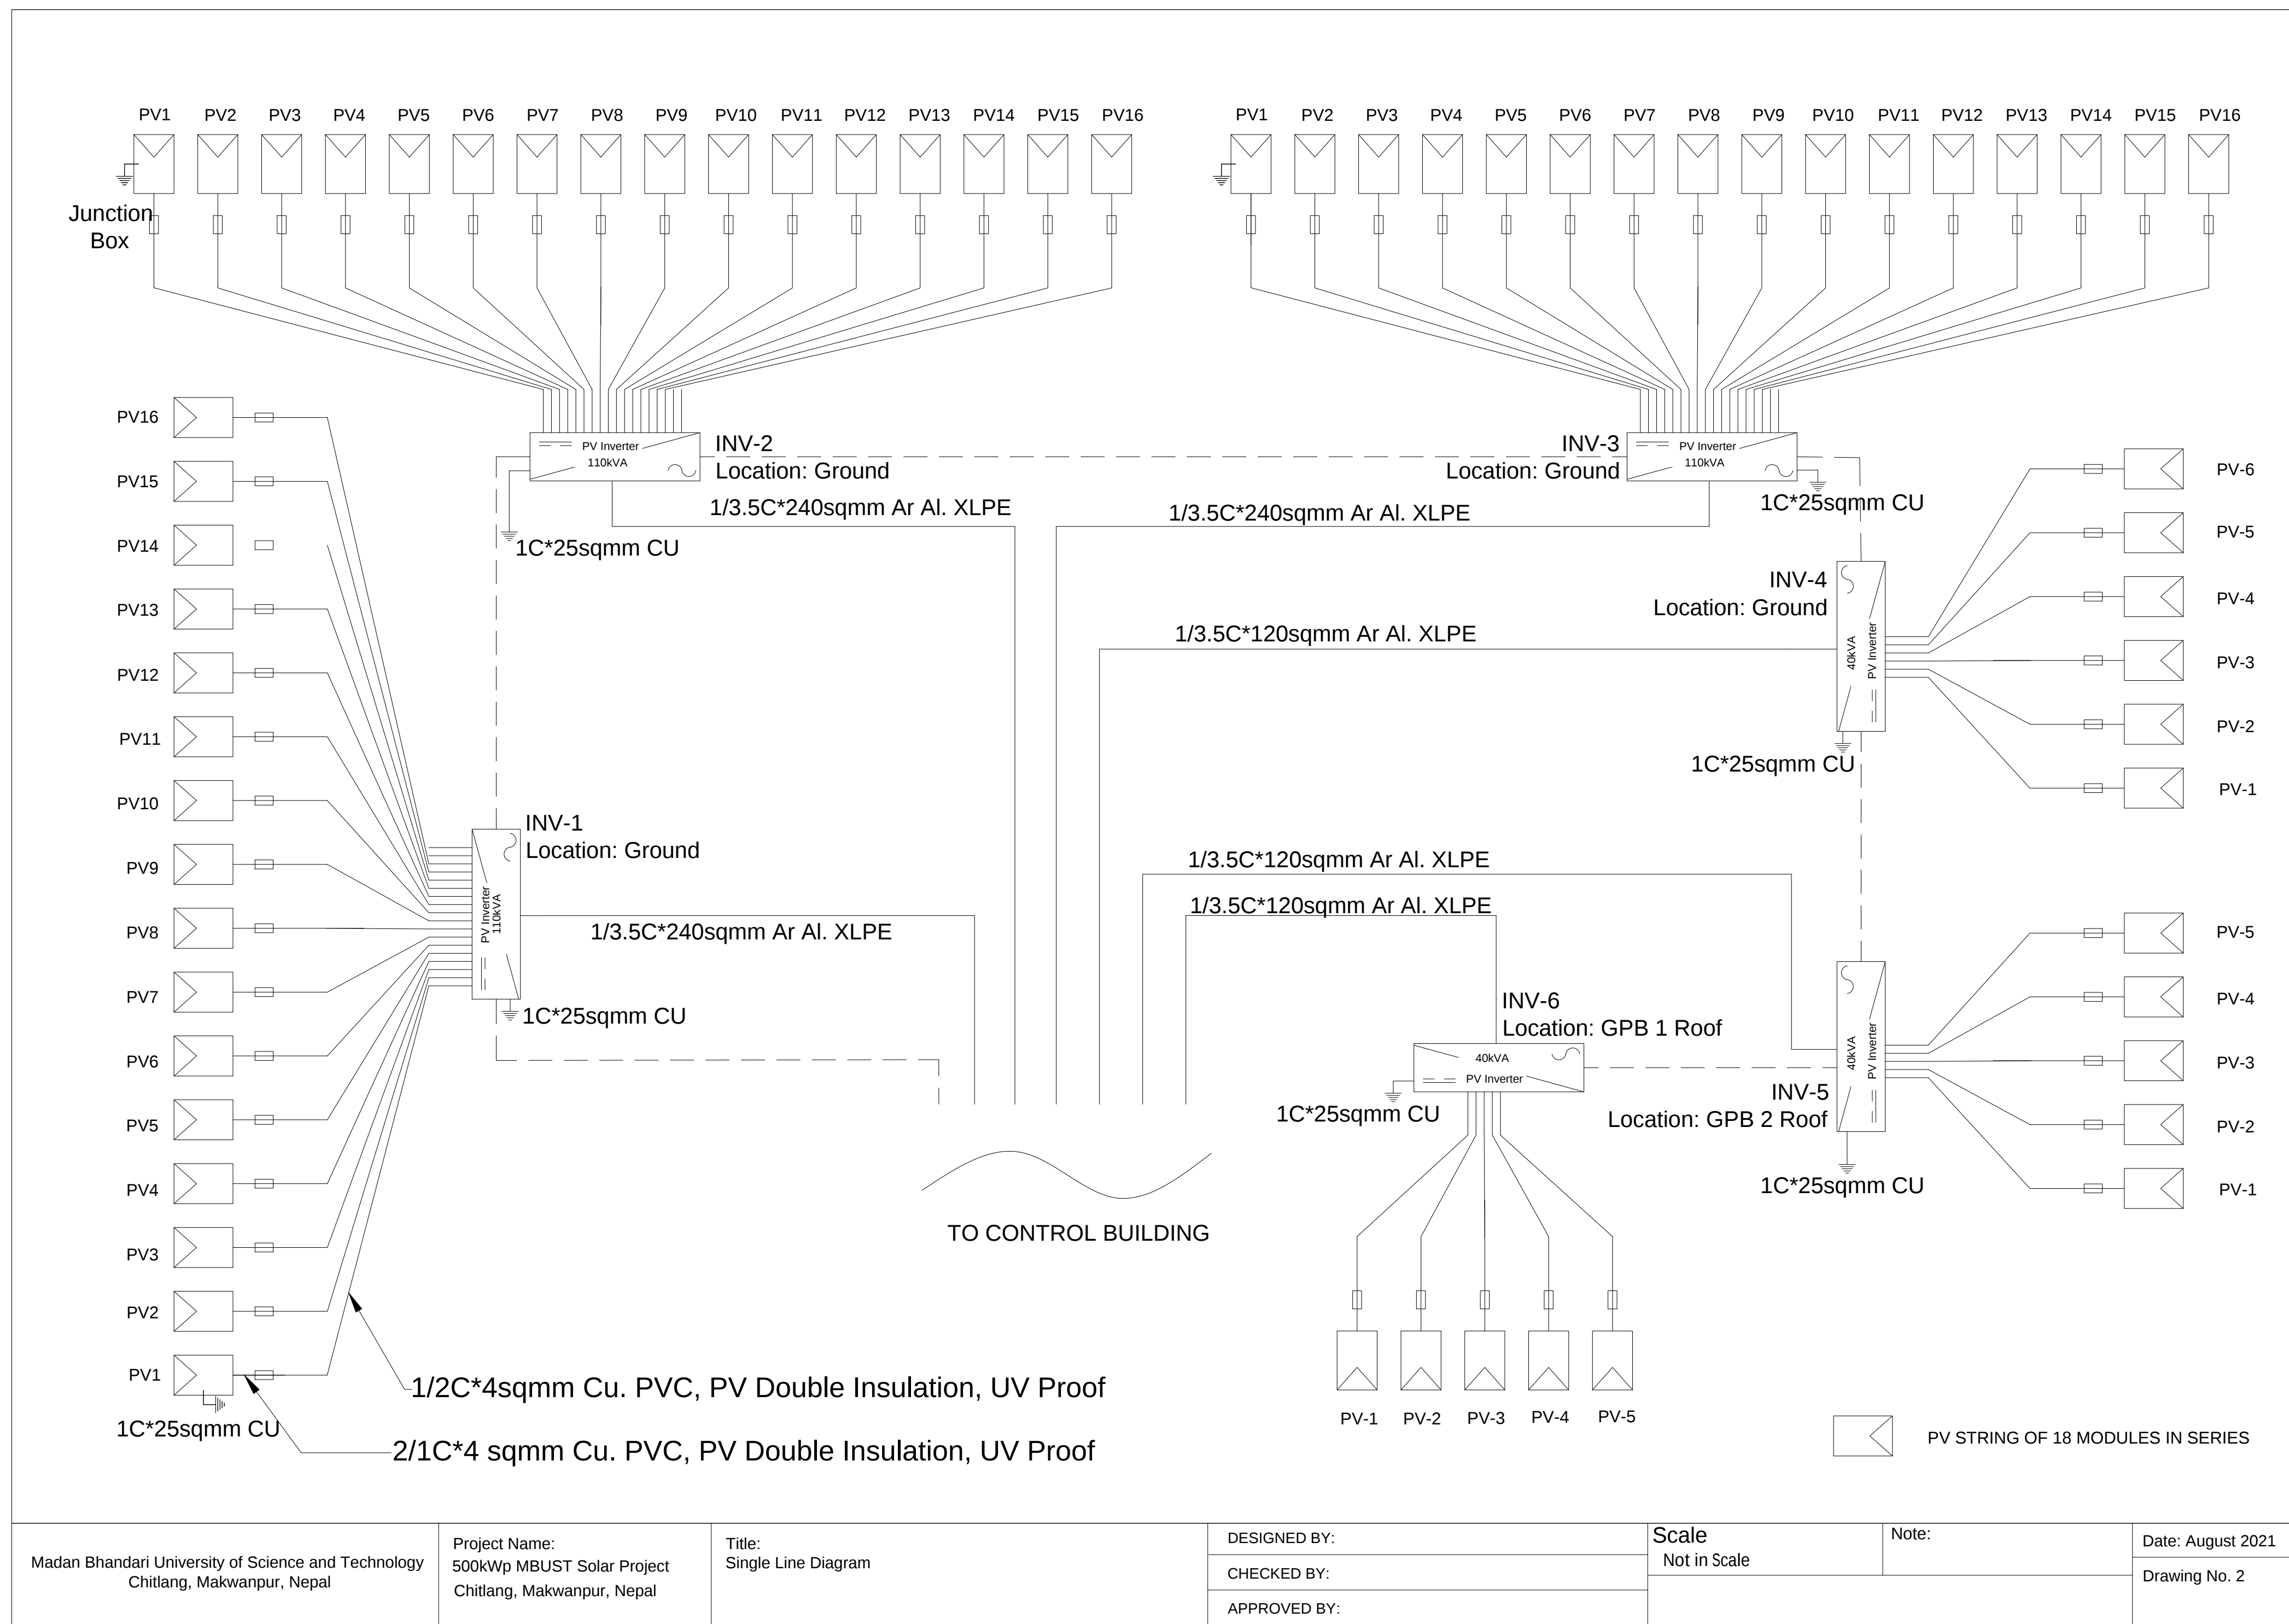

Madan Bhandari University of Science and Technology Chitlang, Makwanpur, Nepal	Project Name: 500kWp MBUST Solar Project Chitlang, Makwanpur, Nepal	Title: Single Line Diagram	DESIGNED BY:	Scale Not in Scale	Note:	Date: August 2021
			CHECKED BY:			Drawing No. 2
			APPROVED BY:			


Control Room

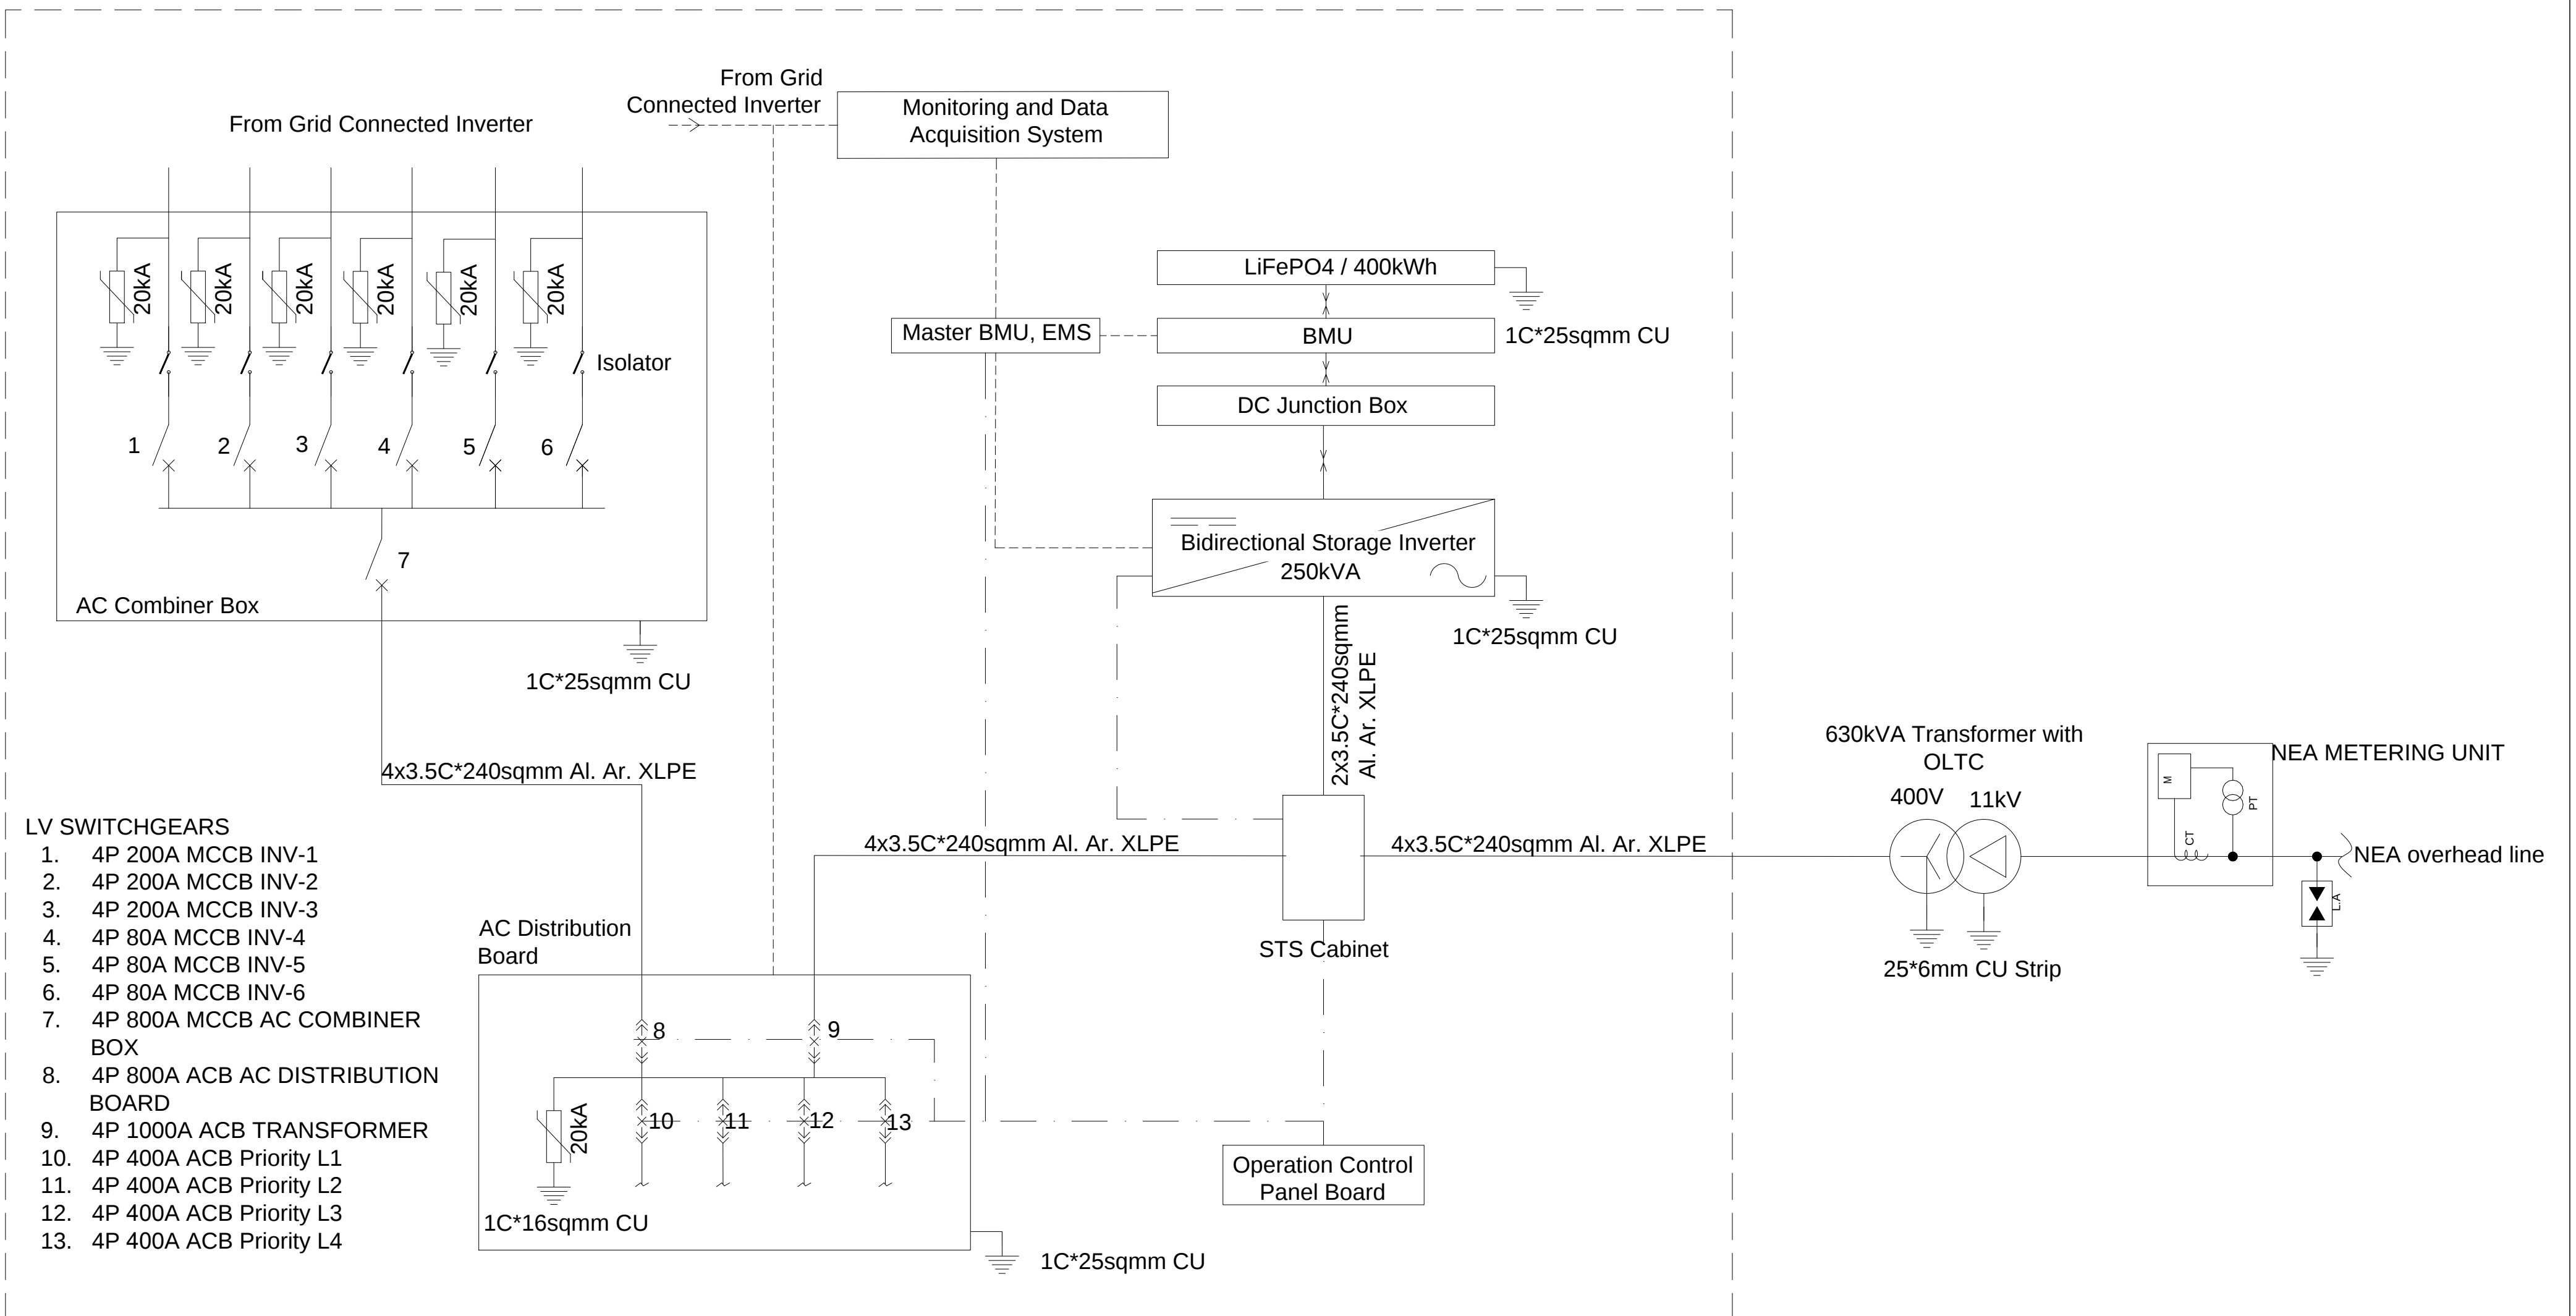

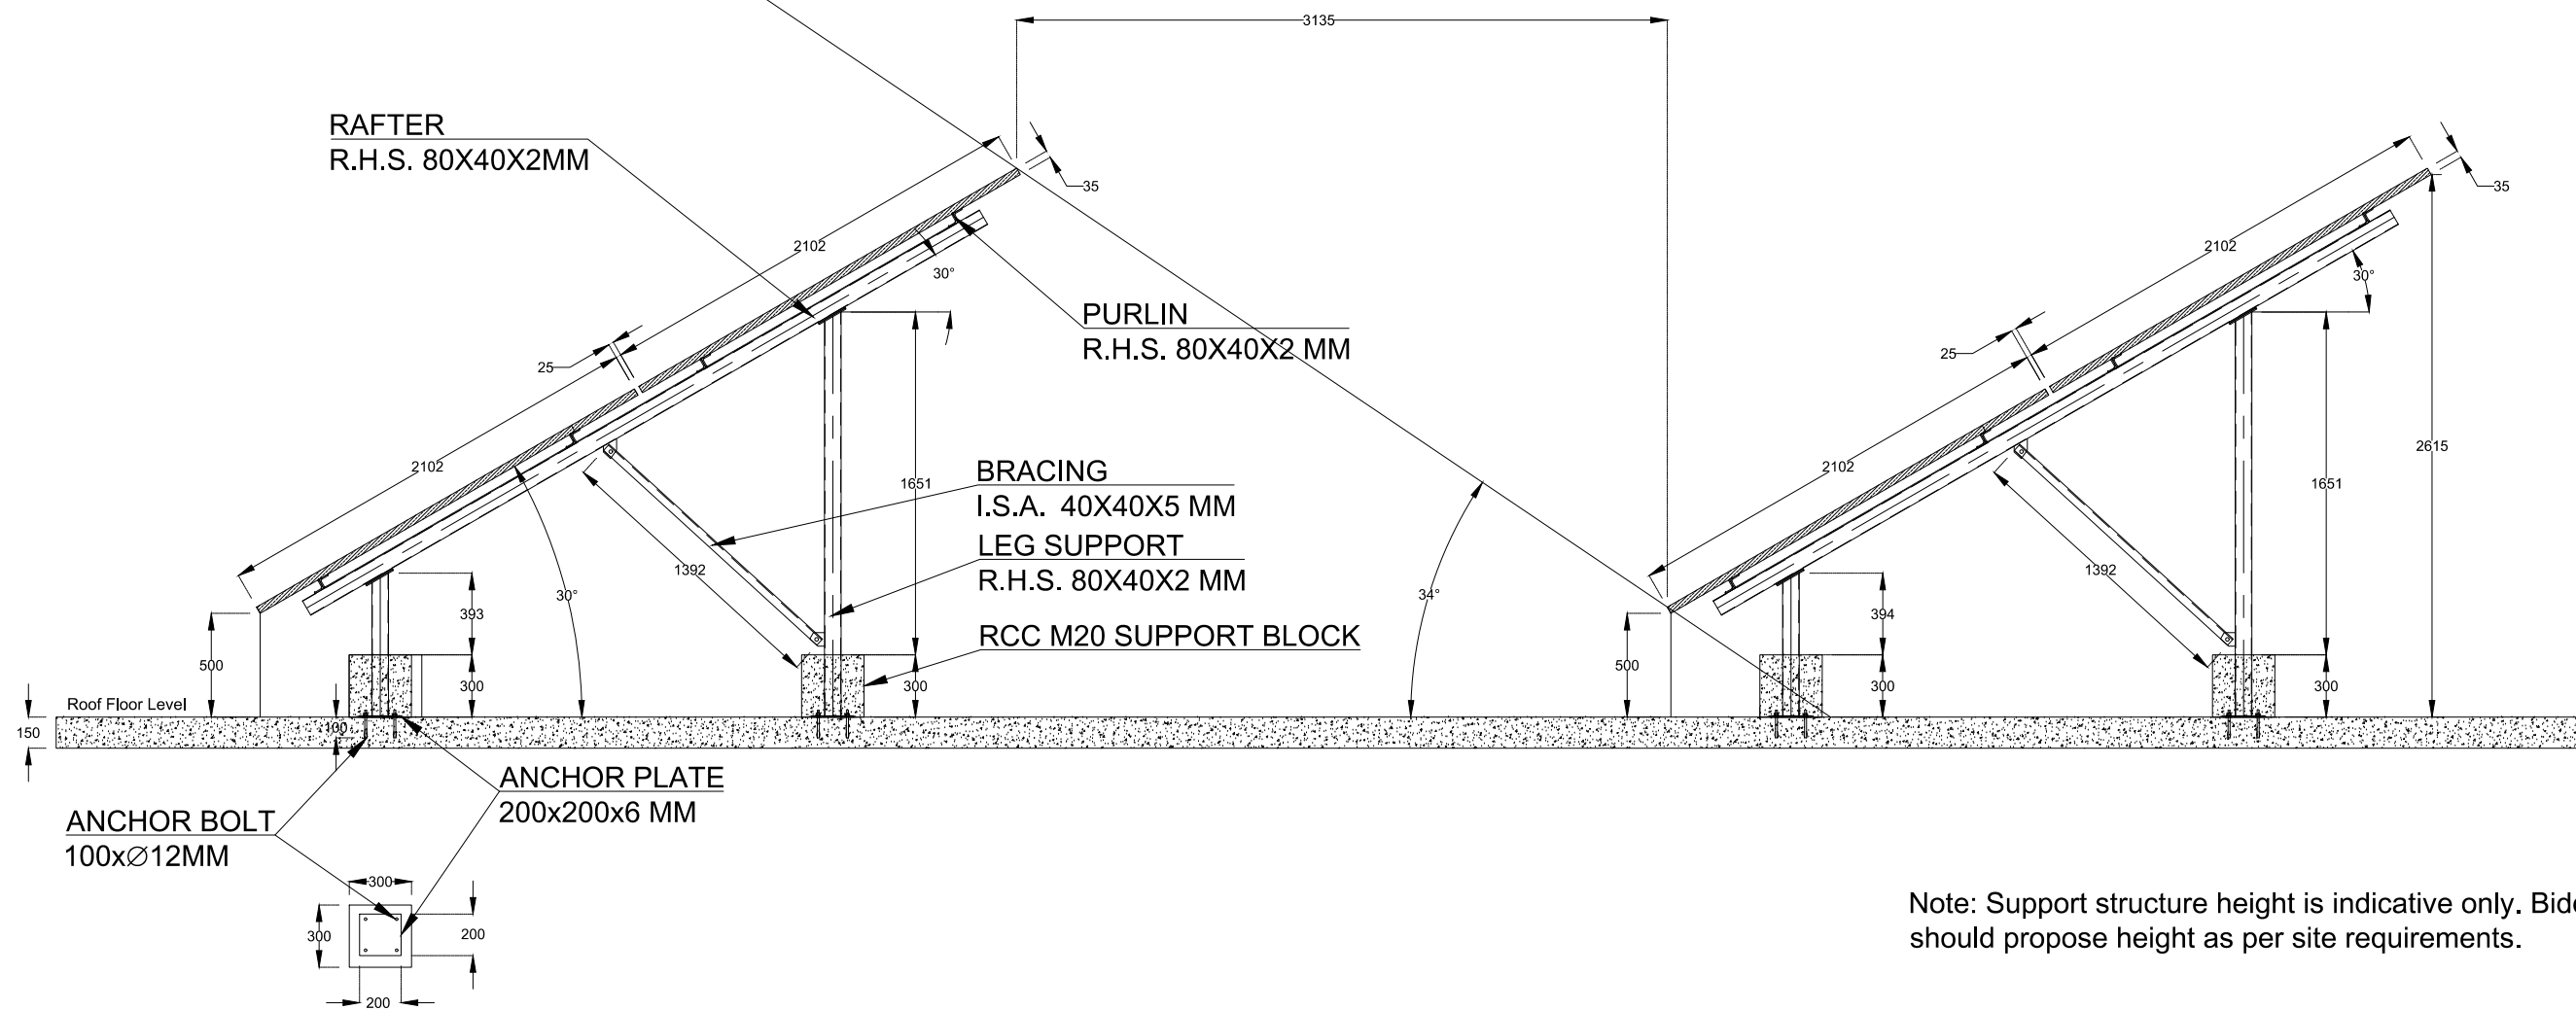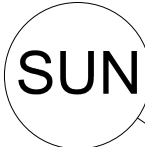

Note: Support structure height is indicative only. Bidder should propose height as per site requirements.

Madan Bhandari University of Science and Technology Chitlang, Makwanpur, Nepal	Project Name: 500kWp MBUST Solar Project Chitlang, Makwanpur, Nepal	Title: Solar Support Structure Details for Roof Mounted System	DESIGNED BY:	Scale Not in Scale	Note:	Date: August 2021
			CHECKED BY:			Drawing No. 4
			APPROVED BY:			

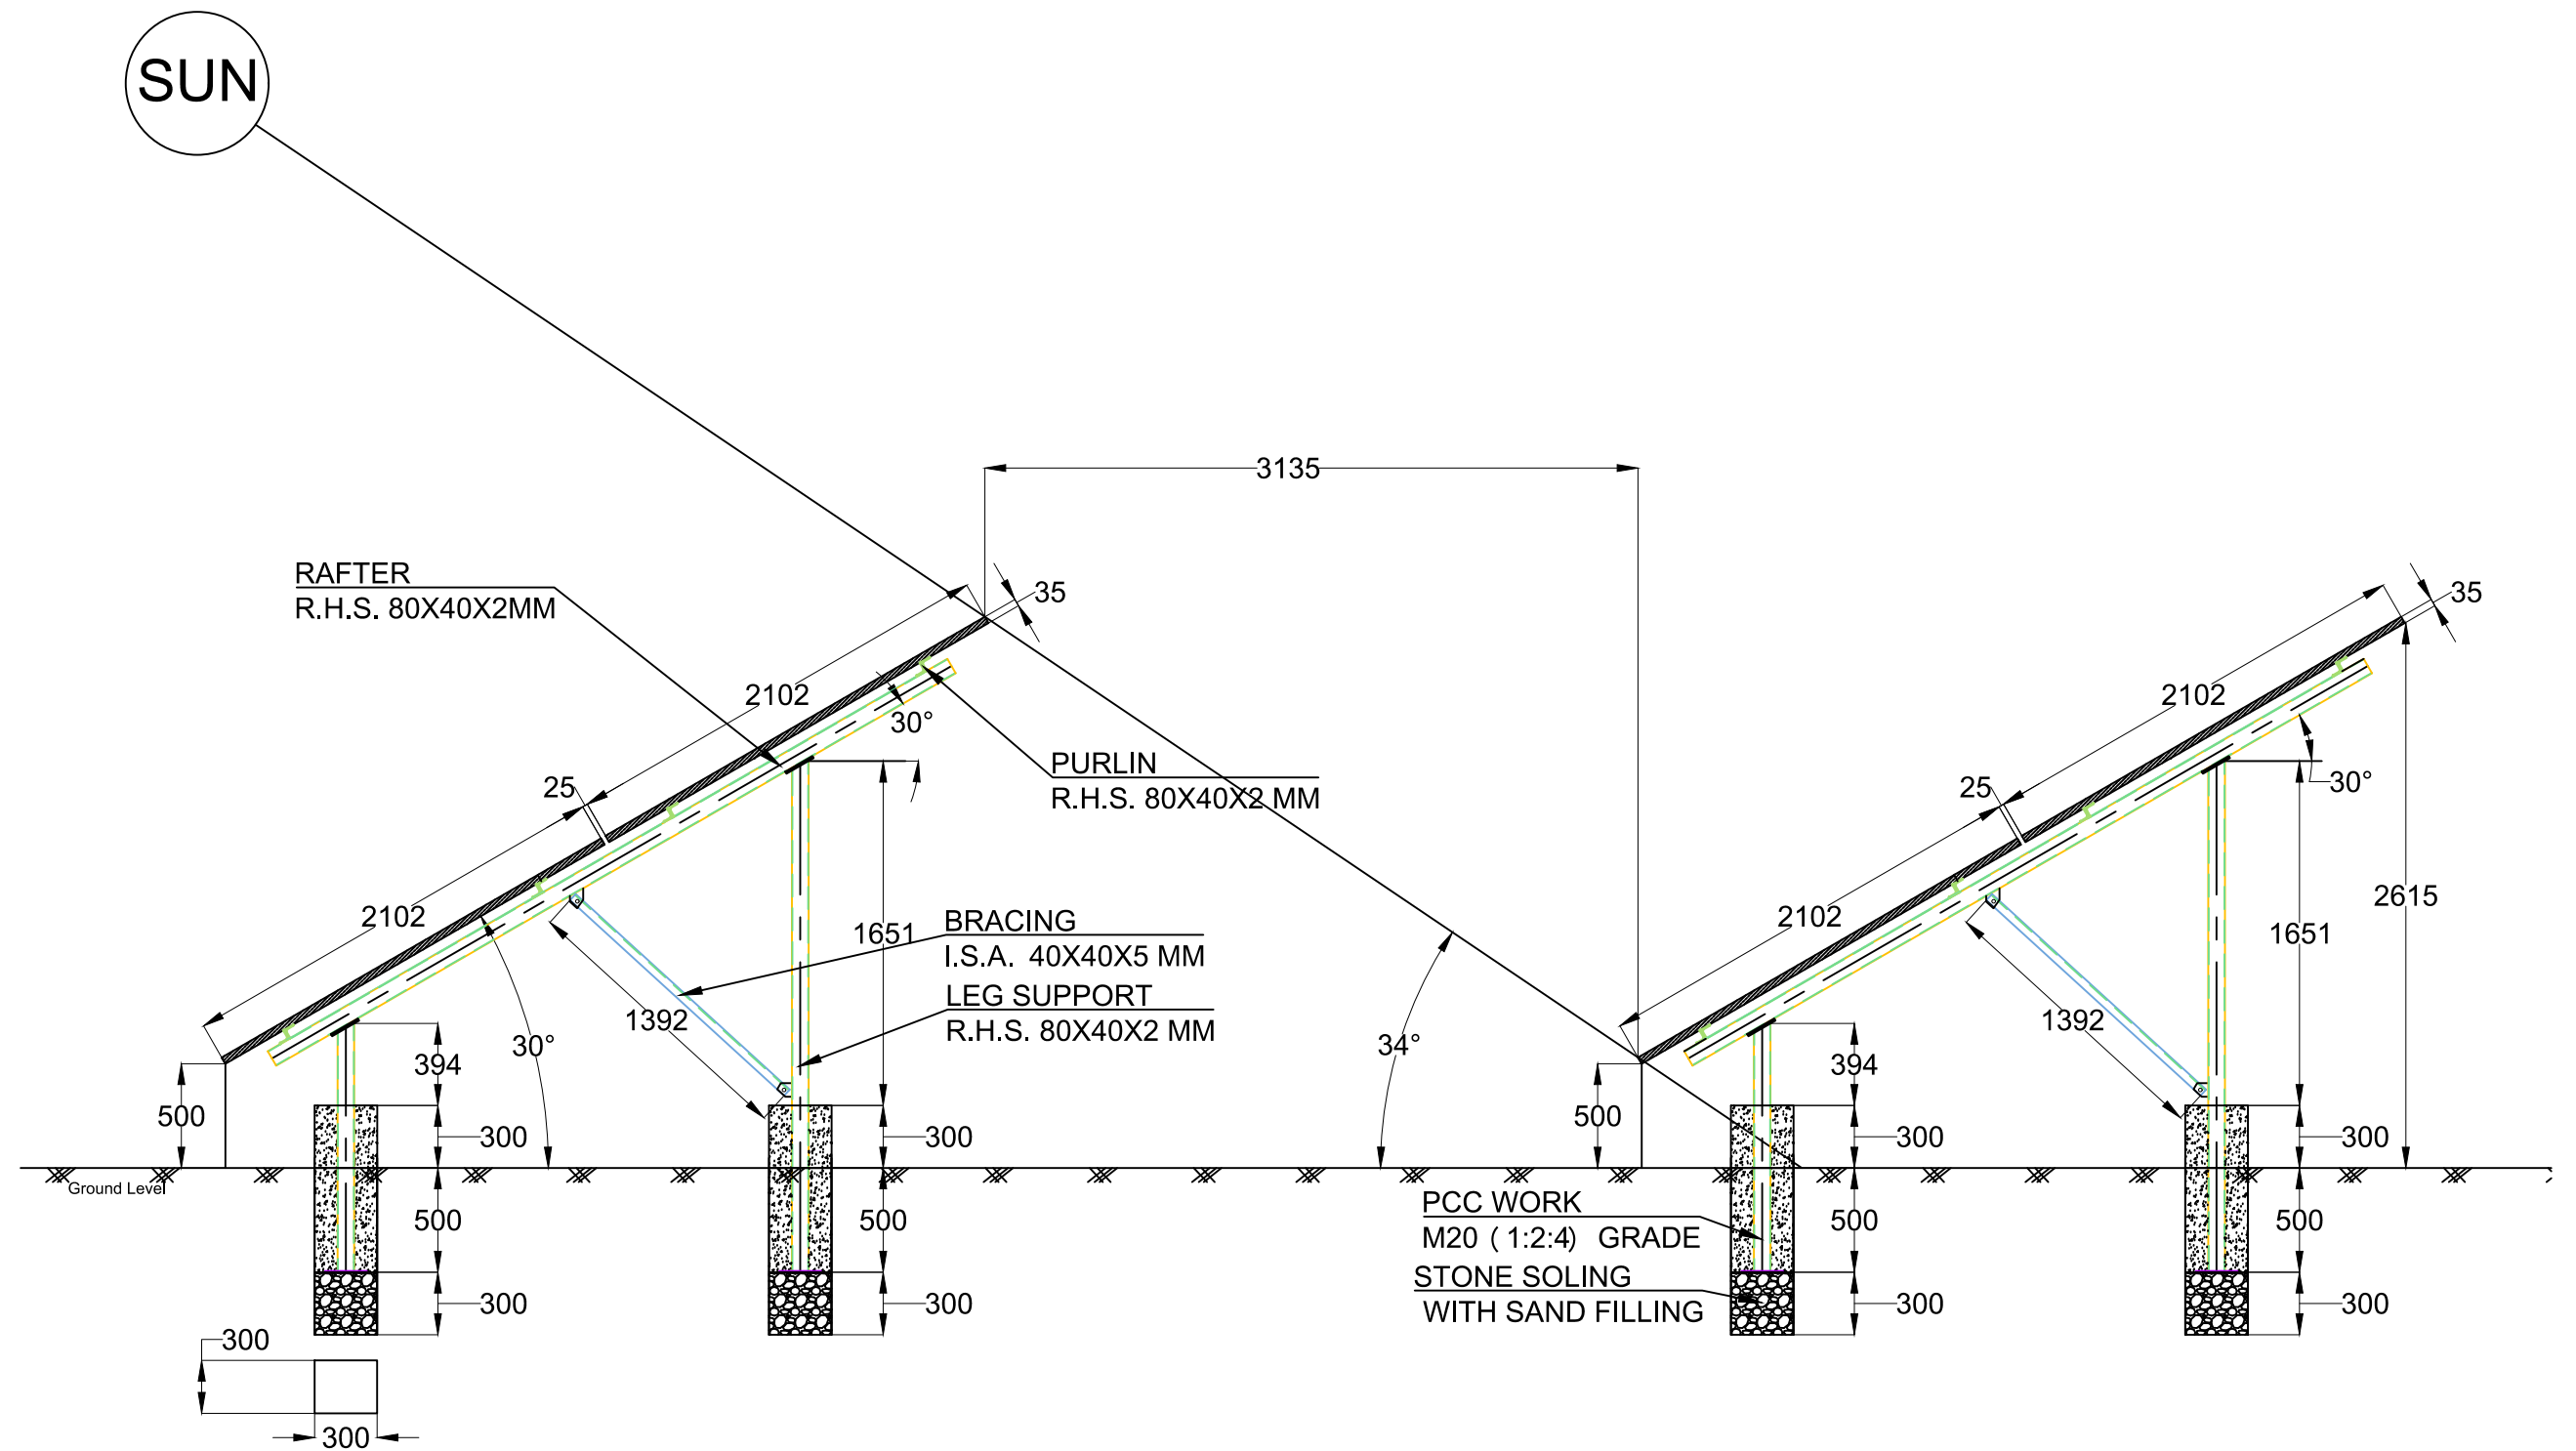

Madan Bhandari University of Science and Technology Chitlang, Makwanpur, Nepal	Project Name: 500kWp MBUST Solar Project Chitlang, Makwanpur, Nepal	Title: Solar Support Structure Details for Ground Mounted System	DESIGNED BY:	Scale Not in Scale	Note:	Date: August 2021
			CHECKED BY:			Drawing No. 5
			APPROVED BY:			