

MADAN BHANDARI UNIVERSITY OF SCIENCE AND
TECHNOLOGY DEVELOPMENT BOARD
SETOPATI, WARD 18, LALITPUR METROPOLITAN CITY, NEPAL

DETAIL ARCHITECTURAL AND ENGINEERING
DESIGN WORK OF GRADUATE PROGRAM
BUILDINGS IIV AND EXTERNAL
INFRASTRUCTURE PLANNING INCLUDING
LANDSCAPING WORKS

AT

CHITLAG, THAHA MUNICIPALITY WARD NO.9,
MAKWANPUR DISTRICT, BAGMATI PROVINCE, NEPAL

FINAL SUBMISSION
FEB., 2022

VAASTUSHILPA ASSOCIATES PVT. LTD.
GWARKO, LALITPUR

DRAWING INDEX

CIVIL

C-001	LOCATION PLAN
C-101	SITE PLAN
C-110	LANDSCAPE PLAN
C-150	SITE SECTIONS
C-151	SITE SECTION X-X BLOW UP
C-152	SITE SECTION Y-Y BLOW UP
C-153	SITE SECTION Z-Z BLOW UP
C-201	RETAINING WALL-SITE PLAN
C-202	RETAINING DETAILS
C-203	RETAINING DETAILS
C-204	RETAINING DETAILS
C-205	RETAINING DETAILS
C-401	LIGHT LAYOUT -SITE PLAN
C-501	WATER SUPPLY TRENCH LAYOUT MASTER PLAN
C-502	WATER SUPPLY MANHOLE LAYOUT MASTER PLAN
C-503	WATER SUPPLY PIPE LAYOUT MASTER PLAN
C-510A	GREY, BLACK, &RAIN WATER PIPE LAYOUT MASTER PLAN (PART A)
C-510B	GREY, BLACK, &RAIN WATER PIPE LAYOUT MASTER PLAN (PART B)
C-520	STORM WATER DRAIN LAYOUT MASTER PLAN
C-530	FIREFIGHTING LAYOUT MASTER PLAN
C-531	DETAIL AT B(SCHEMATIC DIAGRAM OF PUMP HOUSE)
C-601	RAIN WATER COLLECTION TANK 1 DETAILS
C-602	RAIN WATER COLLECTION TANK 2 DETAILS
C-603	UNDERGROUND WATER COLLECTION TANK DETAILS
C-604	FIREFIGHTING WATER TANK DETAILS

ARCHITECTURAL

A-001	3D VIEWS
A-101	GROUND FLOOR PLAN
A-102	FIRST FLOOR PLAN
A-103	SECOND FLOOR PLAN
A-104	THIRD FLOOR PLAN
A-105	ROOF PLAN
A-201	ELEVATION
A-202	ELEVATION
A-203	ELEVATION
A-204	ELEVATION
A-251	SECTIONS
A-252	SECTIONS
A-301	GROUND FLOOR FINISH PLAN
A-302	FIRST FLOOR FINISH PLAN
A-303	SECOND FLOOR FINISH PLAN
A-304	THIRD FLOOR FINISH PLAN
A-305	ROOF FINISH PLAN
A-401	STAIRCASE DETAILS
A-402	STAIRCASE DETAILS
A-403	STAIRCASE DETAILS
A-404	STAIRCASE DETAILS
A-405	STAIRCASE DETAILS
A-501	OPENING DETAILS
A-502	OPENING DETAILS
A-503	OPENING DETAILS

A-504	OPENING DETAILS
A-505	OPENING DETAILS
A-506	OPENING DETAILS
A-507	OPENING DETAILS
A-508	OPENING DETAILS
A-509	OPENING DETAILS
A-510	OPENING DETAILS
A-601	TOILET DETAILS
A-602	TOILET DETAILS
A-603	TOILET DETAILS
A-604	TOILET DETAILS
A-605	TOILET DETAILS
A-606	TOILET DETAILS
A-701	GROUND FLOOR REFLECTED CEILING PLAN
A-702	FIRST FLOOR REFLECTED CEILING PLAN
A-703	SECOND FLOOR REFLECTED CEILING PLAN
A-704	THIRD FLOOR REFLECTED CEILING PLAN
A-801	WALL SECTIONS
A-802	WALL SECTIONS
A-803	WALL SECTIONS

STRUCTURAL

S-001	GENERALS
S-002	TYPICAL DETAILS
S-003	TYPICAL DETAILS
S-101	RAFT TOP AND BOTTOM DETAILS
S-102	RAFT REBAR SECTION DETAILS
S-103	LIFT PIT PLAN AND SECTION DETAILS
S-201	COLUMN AND BASEMENT WALL PLAN
S-202	COLUMN SCHEDULE & TYPICAL BASEMENT WALL SECTION DETAILS
S-301	BEAM PLAN FOR GROUND FLOOR LEVEL
S-302	BEAM PLAN FOR FIRST FLOOR LEVEL
S-303	BEAM PLAN FOR SECOND FLOOR LEVEL
S-304	BEAM PLAN FOR THIRD FLOOR LEVEL
S-305	BEAM PLAN FOR TOP FLOOR LEVEL
S-351	LONGITUDINAL BEAM PROFILES FOR GROUND FLOOR LEVEL & SECTIONS
S-352	LONGITUDINAL BEAM PROFILES FOR GROUND FLOOR LEVEL & SECTIONS
S-353	LONGITUDINAL BEAM PROFILES FOR GROUND FLOOR LEVEL & SECTIONS
S-354	LONGITUDINAL BEAM PROFILES FOR FIRST FLOOR LEVEL & SECTIONS
S-355	LONGITUDINAL BEAM PROFILES FOR FIRST FLOOR LEVEL & SECTIONS
S-356	LONGITUDINAL BEAM PROFILES FOR FIRST FLOOR LEVEL & SECTIONS AND SECONDARY BEAM PROFILE AND SECTION DETAILS
S-357	LONGITUDINAL BEAM PROFILES FOR FIRST FLOOR LEVEL & SECTIONS
S-358	LONGITUDINAL BEAM PROFILES FOR SECOND FLOOR LEVEL & SECTIONS
S-359	LONGITUDINAL BEAM PROFILES FOR SECOND FLOOR LEVEL & SECTIONS
S-360	LONGITUDINAL BEAM PROFILES FOR SECOND FLOOR LEVEL & SECTIONS

S-361	LONGITUDINAL BEAM PROFILES FOR SECOND FLOOR LEVEL & SECTIONS
S-362	LONGITUDINAL BEAM PROFILES FOR THIRD FLOOR LEVEL & SECTIONS
S-363	LONGITUDINAL BEAM PROFILES FOR THIRD FLOOR LEVEL & SECTIONS
S-364	LONGITUDINAL BEAM PROFILES FOR THIRD FLOOR LEVEL & SECTIONS
S-365	LONGITUDINAL BEAM PROFILES FOR THIRD FLOOR LEVEL & SECTIONS
S-366	LONGITUDINAL BEAM PROFILES FOR TOP FLOOR LEVEL & SECTIONS
S-367	LONGITUDINAL BEAM PROFILES FOR TOP FLOOR LEVEL & SECTIONS
S-401	SLAB REBAR PLAN DETAILS FOR GROUND FLOOR LEVEL & SECTIONS
S-402	SLAB REBAR PLAN DETAILS FOR FIRST FLOOR LEVEL & SECTIONS
S-403	LAB REBAR PLAN DETAILS FOR SECOND FLOOR LEVEL & SECTIONS
S-404	LAB REBAR PLAN DETAILS FOR THIRD FLOOR LEVEL & SECTIONS
S-405	LAB REBAR PLAN DETAILS FOR TOP FLOOR LEVEL & SECTIONS
S-501	STAIRCASE PLAN & SECTION DETAILS,NOSING BAR & STIRRUP DETAILS
S-502	STAIRCASE PLAN & SECTION DETAILS,NOSING BAR & STIRRUP DETAILS

ELECTRICAL

E-101	BASEMENT FEEDER PLAN
E-102	GROUND FLOOR FEEDER PLAN
E-103	FIRST FLOOR FEEDER PLAN
E-104	SECOND FLOOR FEEDER PLAN
E-105	TOP FLOOR FEEDER PLAN
E-201	BASEMENT LIGHT LAYOUT PLAN
E-202	GROUND FLOOR LIGHT LAYOUT PLAN
E-203	FIRST FLOOR LIGHT LAYOUT PLAN
E-204	SECOND FLOOR LIGHT LAYOUT PLAN
E-205	TOP FLOOR LIGHT LAYOUT PLAN
E-301	BASEMENT POWER LAYOUT PLAN
E-302	GROUND FLOOR POWER LAYOUT PLAN
E-303	FIRST FLOOR POWER LAYOUT PLAN
E-304	SECOND FLOOR POWER LAYOUT PLAN
E-305	TOP FLOOR POWER LAYOUT PLAN
E-401	BASEMENT FA PLAN
E-402	GROUND FLOOR FA PLAN
E-403	FIRST FLOOR FA PLAN
E-404	SECOND FLOOR FA PLAN
E-405	TOP FLOOR FA PLAN
E-501	SINGLE LINE DIAGRAM-MEP
E-502	SINGLE LINE DIAGRAM-MDB
E-503	SINGLE LINE DIAGRAM-DB-BA,GF1,GF2
E-504	SINGLE LINE DIAGRAM-DB-FF1,FF2
E-504	SINGLE LINE DIAGRAM-DB-SF1,SF2,TF
E-505	SINGLE LINE DIAGRAM FOR TYPICAL SDB
E-601	LIGHTING PROTECTION SYSTEM ON SITE PLAN
E-602	LIGHTING PROTECTION SYSTEM ON ELEVATION

NOTE:
1.ONLY WRITTEN DIMENSIONS SHALL BE FOLLOWED,
DRAWINGS SHALL NOT BE MEASURED.
2. ANY DISCREPANCY IF FOUND SHALL BE REPORTED
TO THE SITE ENGINEER

CLIENT:

**MADAN BHANDARI UNIVERSITY OF
SCIENCE AND TECHNOLOGY
DEVELOPMENT BOARD**
SETOPATI, WARD 18,
LALITPUR METROPOLITAN CITY, NEPAL

PROJECT:
DETAIL ARCHITECTURAL AND ENGINEERING DESIGN
WORK OF GRADUATE PROGRAM BUILDINGS III &IV
AND EXTERNAL INFRASTRUCTURE PLANNING
INCLUDING LANDSCAPING WORKS
AT
CHITLAG, THAHA MUNICIPALITY WARD NO.9,
MAKWANPUR DISTRICT, BAGMATI PROVINCE, NEPAL
CONTRACT NO.: MBUSTDB/CS/QCBS - 01/2078/79
(PACKAGE1-GPB 4 BUILDING & LAND DEVELOPMENT)

CONSULTANT:

VAASTUSHILPA ASSOCIATES PVT. LTD.
GWARKO, LALITPUR

PRINCIPAL ARCHITECT:

MITRA GURAU
(NEC:1375 "Architecture" "A")

ARCHITECT:

KABITA MAHARJAN
(NEC: 833"Architecture" "A")

REVIEWED BY:

DRAWING TITLE:

DRAWING INDEX

REVISIONS:

NUM.	DESCRIPTION	DATE
A	PRILIMINARY	2021/10/29
B	DRAFT	2022/02/06
C	FINAL	2022/02/25

PROJECT NO.: MBUSTDB/CS/QCBS - 01/2078/79

SCALE: NTS

DATE: FEB. 2022

REVISION NO.: N/A

SHEET NO.

I-001

SANITARY/ FIREFIGHTING

P-001	LEGEND
P-101	COLD,HOT AND REUSE WATER PIPE LAYOUT BASEMENT FLOOR PLAN
P-102	COLD,HOT AND REUSE WATER PIPE LAYOUT GROUND FLOOR PLAN
P-103	COLD,HOT AND REUSE WATER PIPE LAYOUT FIRST FLOOR PLAN
P-104	COLD,HOT AND REUSE WATER PIPE LAYOUT SECOND FLOOR PLAN
P-105	COLD,HOT AND REUSE WATER PIPE LAYOUT TOP FLOOR PLAN
P-106	COLD,HOT AND REUSE WATER PIPE LAYOUT ROOF FLOOR PLAN
P-107	ISOMETRIC SECTION OF COLD,HOT AND REUSE WATER PIPE LAYOUT
P-201	GREY,BLACK AND RAINWATER PIPE LAYOUT BASEMENT FLOOR PLAN
P-202	GREY,BLACK AND RAINWATER PIPE LAYOUT GROUND FLOOR PLAN
P-203	GREY,BLACK AND RAINWATER PIPE LAYOUT FIRST FLOOR PLAN
P-204	GREY,BLACK AND RAINWATER PIPE LAYOUT SECOND FLOOR PLAN
P-205	GREY,BLACK AND RAINWATER PIPE LAYOUT TOP FLOOR PLAN
P-206	GREY,BLACK AND RAINWATER PIPE LAYOUT ROOF FLOOR PLAN
P-207	ISOMETRIC SECTION OF GREY WATER PIPE LAYOUT
P-208	ISOMETRIC SECTION OF BLACK WATER PIPE LAYOUT
P-301	FIREFIGHTING PIPE LAYOUT BASEMENT FLOOR PLAN
P-302	FIREFIGHTING PIPE LAYOUT TYPICAL FLOOR PLAN
P-303	ISOMETRIC SECTION OF FIREFIGHTING WATER PIPE LAYOUT

NOTE:
1. ONLY WRITTEN DIMENSIONS SHALL BE FOLLOWED, DRAWINGS SHALL NOT BE MEASURED.
2. ANY DISCREPANCY IF FOUND SHALL BE REPORTED TO THE SITE ENGINEER

CLIENT:

**MADAN BHANDARI UNIVERSITY OF
SCIENCE AND TECHNOLOGY
DEVELOPMENT BOARD**

SETOPATI, WARD 18,
LALITPUR METROPOLITAN CITY, NEPAL

PROJECT:
DETAIL ARCHITECTURAL AND ENGINEERING DESIGN
WORK OF GRADUATE PROGRAM BUILDINGS III & IV
AND EXTERNAL INFRASTRUCTURE PLANNING
INCLUDING LANDSCAPING WORKS
AT
CHITLAG, THAHA MUNICIPALITY WARD NO.9,
MAKWANPUR DISTRICT, BAGMATI PROVINCE, NEPAL
CONTRACT NO.: MBUSTDB/CS/QCBS - 01/2017/79
(PACKAGE1-GPB 4 BUILDING & LAND DEVELOPMENT)

CONSULTANT:

VAASTUSHILPA ASSOCIATES PVT. LTD.
GWARKO,LALITPUR

PRINCIPAL ARCHITECT:

MITRA GURAU
(NEC:1375 "Architecture" "A")

ARCHITECT:

KABITA MAHARJAN
(NEC: 833"Architecture" "A")

REVIEWED BY:

DRAWING TITLE:

DRAWING INDEX

REVISIONS:

NUM.	DESCRIPTION	DATE
A	PRILIMINARY	2021/10/29
B	DRAFT	2022/02/06
C	FINAL	2022/02/25

PROJECT NO.:	MBUSTDB/CS/QCBS - 01/2078/79
--------------	------------------------------


SCALE: NTS

DATE: FEB. ,2022

REVISION NO.: N/A

SHEET NO.

I-002

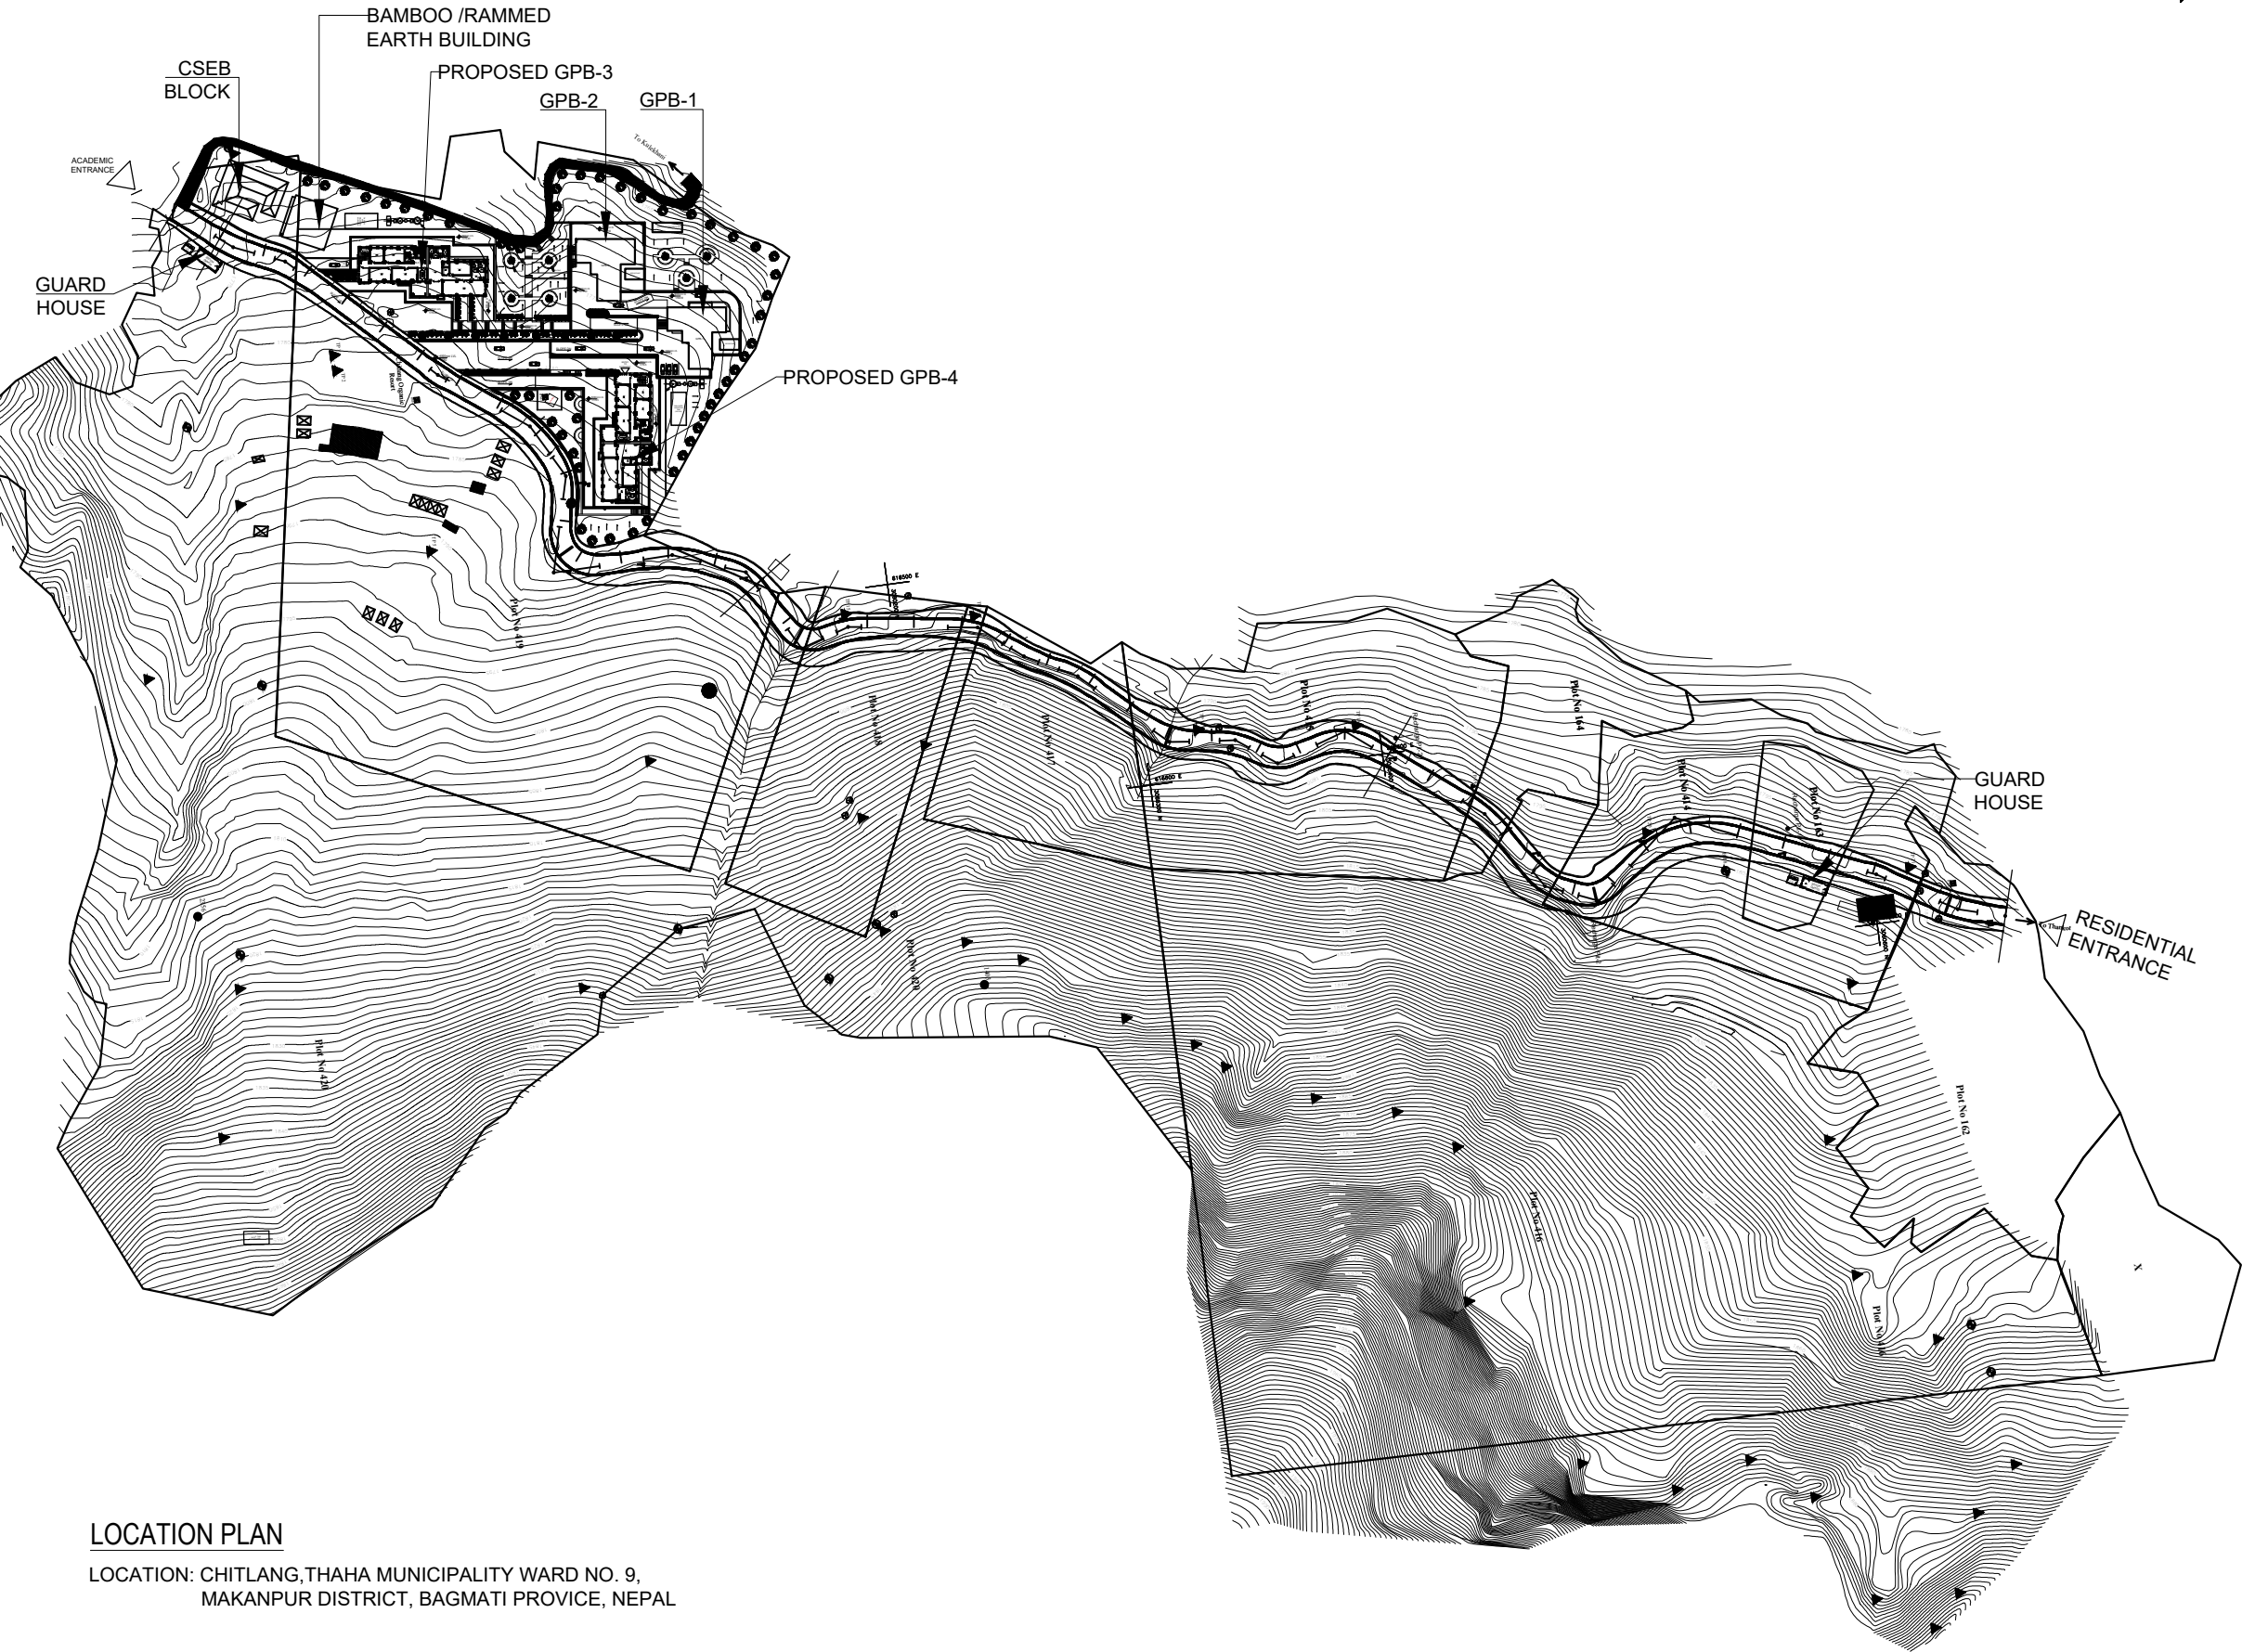

LOCATION PLAN

LOCATION: CHITLANG,THAHA MUNICIPALITY WARD NO. 9,
MAKANPUR DISTRICT, BAGMATI PROVICE, NEPAL



NOTE:
1.ONLY WRITTEN DIMENSIONS SHALL BE FOLLOWED,
DRAWINGS SHALL NOT BE MEASURED.
2. ANY DISCREPANCY IF FOUND SHALL BE REPORTED
TO THE SITE ENGINEER

CLIENT:
**MADAN BHANDARI UNIVERSITY OF
SCIENCE AND TECHNOLOGY
DEVELOPMENT BOARD**
SETOPATI, WARD 18,
LALITPUR METROPOLITAN CITY, NEPAL

PROJECT:
DETAIL ARCHITECTURAL AND ENGINEERING DESIGN
WORK OF GRADUATE PROGRAM BUILDINGS III &IV
AND EXTERNAL INFRASTRUCTURE PLANNING
INCLUDING LANDSCAPING WORKS
AT
CHITLAG, THAHA MUNICIPALITY WARD NO.9,
MAKWANPUR DISTRICT, BAGMATI PROVINCE, NEPAL
CONTRACT NO.: MBUSTDB/CS/QCBS - 01/2078/79
(PACKAGE 1-GPB 4 BUILDING)

CONSULTANT:
VAASTUSHILPA ASSOCIATES PVT. LTD.
GWARKO,LALITPUR

PRINCIPAL ARCHITECT:
MITRA GURAU
(NEC:1375 "Architecture" "A")

ARCHITECT:
KABITA MAHARJAN
(NEC:833 "ARCHITECTURE" "A")

REVIEWED BY:

DRAWING TITLE:
LOCATION PLAN

REVISIONS:		
NUM.	DESCRIPTION	DATE
A	PRILIMINARY	2021/10/29
B	DRAFT	2022/02/06
C	FINAL	2022/02/25

PROJECT NO.:
SCALE: 1:3000
DATE: FEB 25, 2022
REVISION NO.: N/A

SHEET NO.
C-001